



PROPOSED NEW LAYOUT

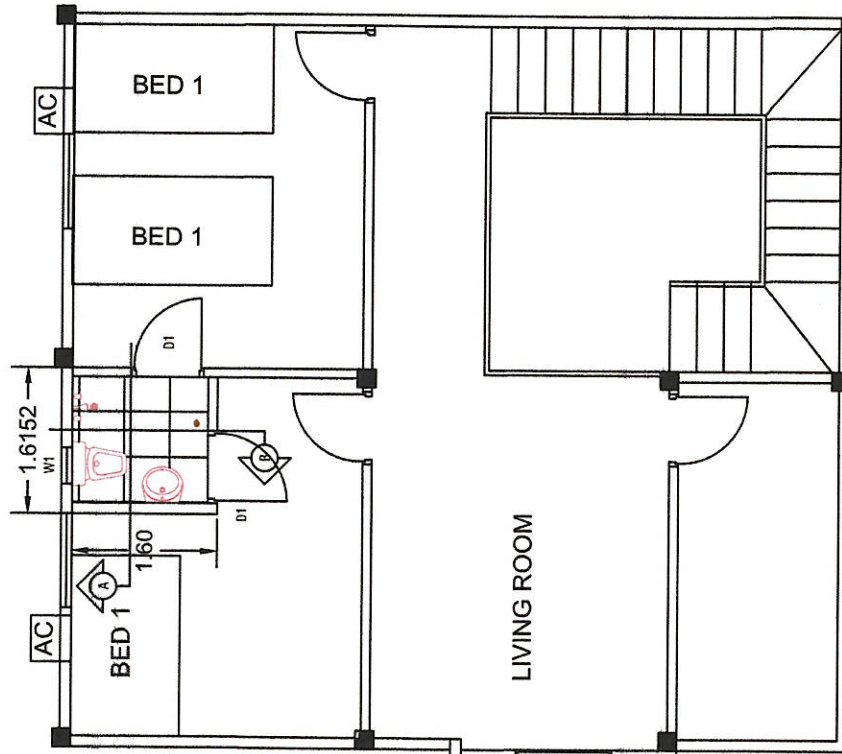

EXISTING LAYOUT

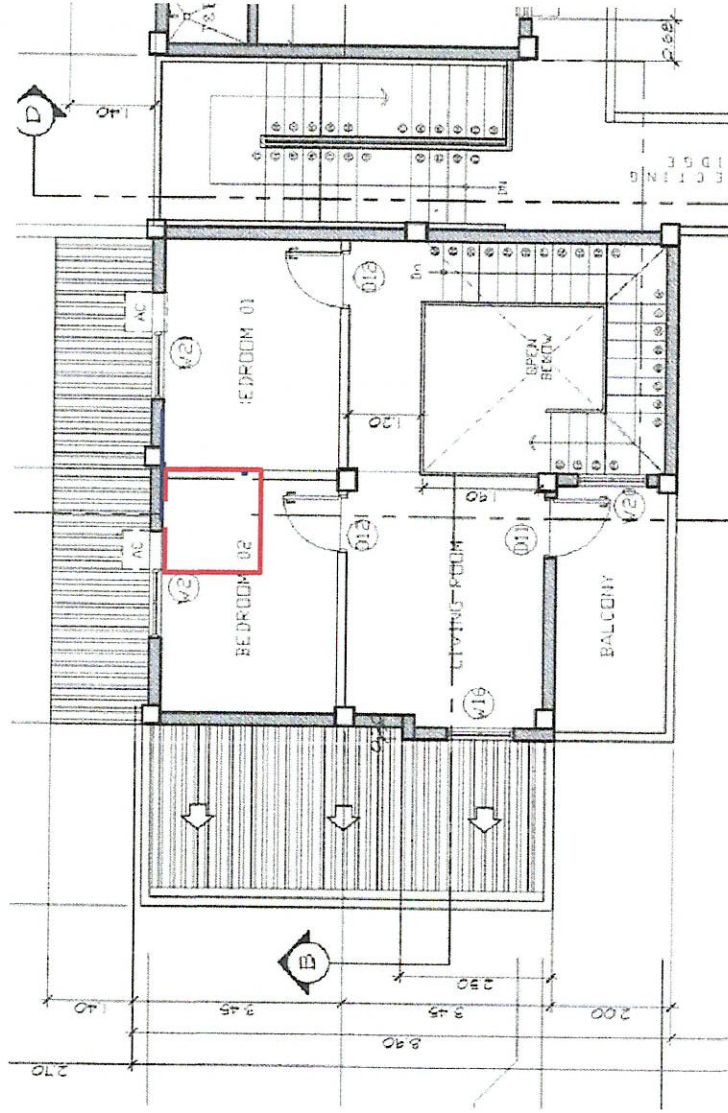

DEPARTMENT OF AGRICULTURE
AGRICULTURAL TRAINING INSTITUTE
 ELLIPTICAL ROAD, DILIMAN, QUEZON CITY

PROJECT TITLE:
 CONSTRUCTION OF ADDITIONAL TOILET AT THE
 2ND FLOOR OF DIRECTORS' QUARTER
 ATI-CO COMPOUND, DILIMAN, QUEZON CITY


PRODUCE BY:
INFRASTRUCTURE SUPPORT TEAM
 ATI-CENTRAL OFFICE
 ELLIPTICAL ROAD, DILIMAN, QUEZON CITY

PREPARED BY:
 JONEL PERALTA, CE
 REGISTERED ENGINEER
 PRC NO. 0011117
 DATE ISSUED: 06/22/12
 CTD MO. NO. 0000000
 PLACED ISSUED

RECOMMENDING APPROVAL:
 ANTONIETA J. ARCEO
 DIRECTOR II

APPROVED BY:
 REMELYN P. RIVERA, MNSA, CESO III
 DIRECTOR IV

SHEET NO.:
 D 01
 03
 01 03

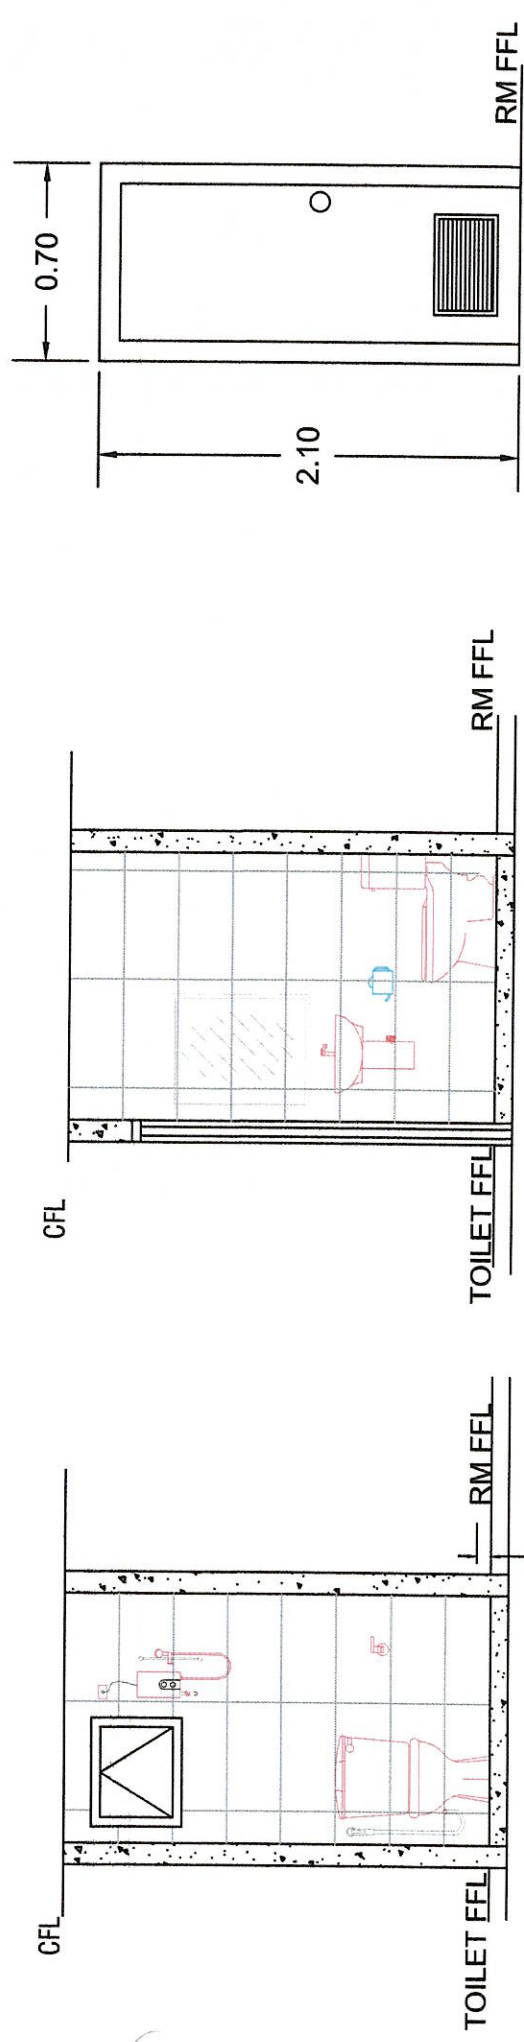

SECTION B-B

SECTION A-A

ROOM T&B

SECTION DETAILS

D1 - PVC DOOR W/
COMPLETE ACCESSORIES



DEPARTMENT OF AGRICULTURE
AGRICULTURAL TRAINING
INSTITUTE
ELLIPTICAL ROAD, DILIMAN, QUEZON CITY

PROJECT TITLE:
CONSTRUCTION OF ADDITIONAL TOILET AT THE
2ND FLOOR OF DIRECTORS' QUARTER
ATI-CO COMPOUND, DILIMAN, QUEZON CITY

PRODUCE BY:
INFRASTRUCTURE
SUPPORT TEAM
ATI-CENTRAL OFFICE
ELLIPTICAL ROAD, DILIMAN, QUEZON CITY


PREPARED BY:
RONEL PERALTA, GE
REGISTERED CIVIL ENGINEER
DATE ISSUED: 02/27/24
DATE MOVED: 02/27/24
DATE MOVED: 02/27/24
DATE MOVED: 02/27/24

RECOMMENDING APPROVAL:
ANTONIETA J. ARCEO
DIRECTOR II

APPROVED BY:
RENE Y. R. REJOTER, MNSA, CESO III
DIRECTOR IV

DESIGN BY:
DATE: 02/27/24
DATE: 02/27/24
DATE: 02/27/24
DATE: 02/27/24

SHEET NO.:
D
02
03
02
03

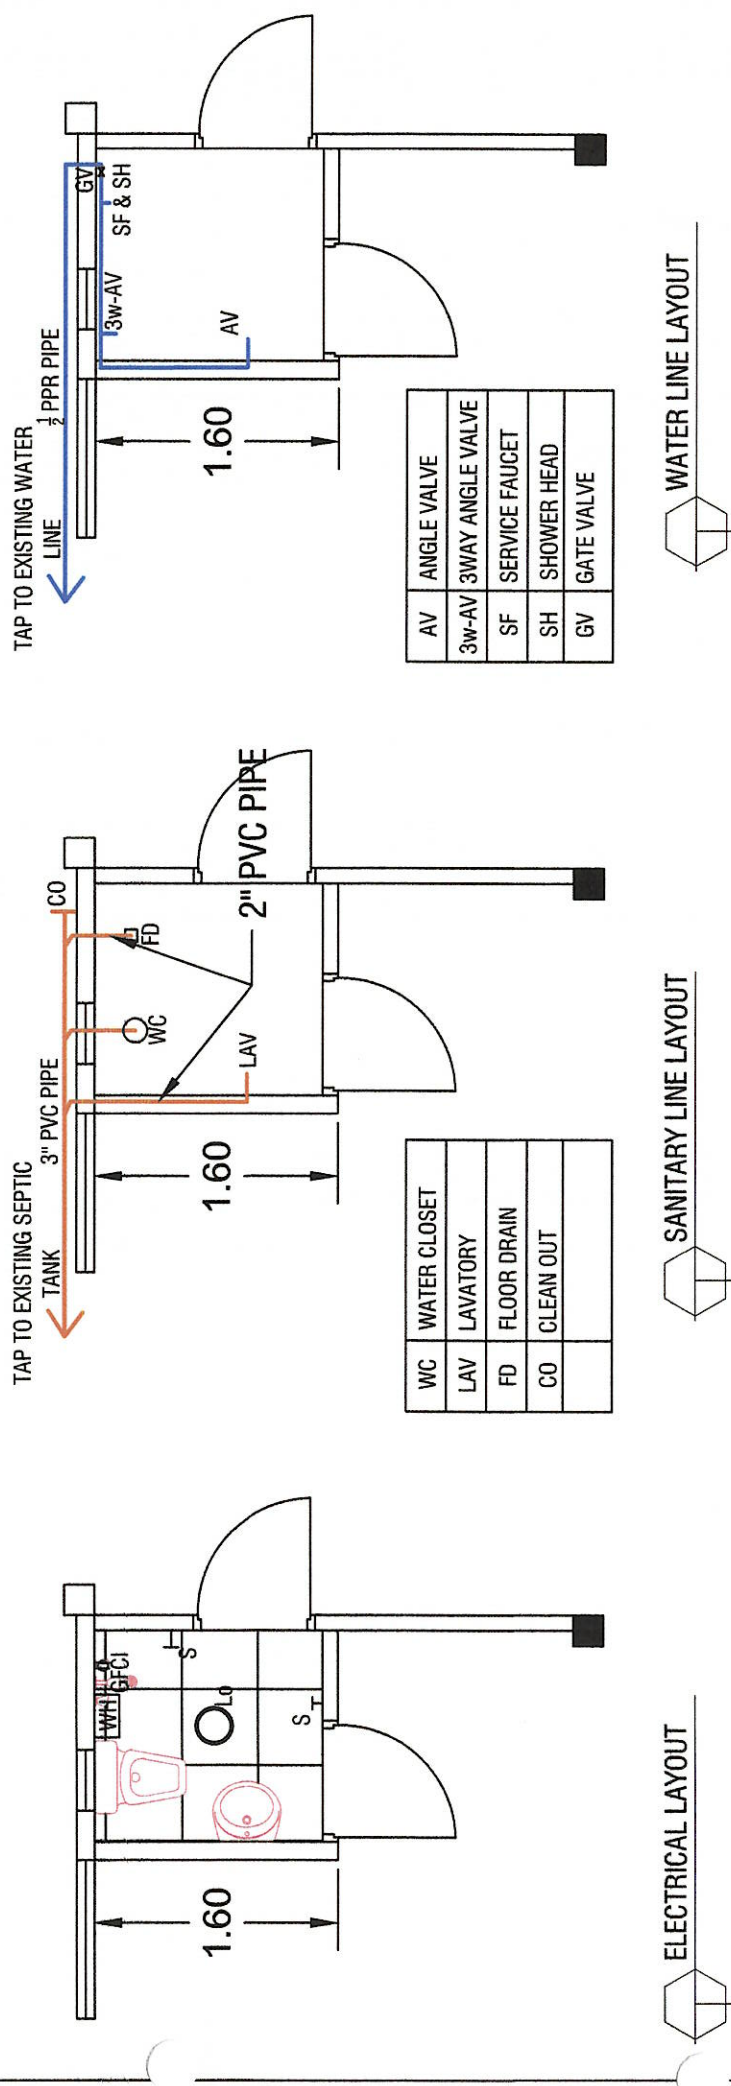

WC	WATER CLOSET
LAV	LAVATORY
FD	FLOOR DRAIN
CO	CLEAN OUT

AV	ANGLE VALVE
3w-AV	3WAY ANGLE VALVE
SF	SERVICE FAUCET
SH	SHOWER HEAD
GV	GATE VALVE

ELECTRICAL LAYOUT



SANITARY LINE LAYOUT



WATER LINE LAYOUT

	DEPARTMENT OF AGRICULTURE AGRICULTURAL TRAINING INSTITUTE ELLIPTICAL ROAD, DILIMAN, QUEZON CITY	PROJECT TITLE: CONSTRUCTION OF ADDITIONAL TOILET AT THE 2ND FLOOR OF DIRECTORS' QUARTER ATH-CC COMPOUND, DILIMAN, QUEZON CITY		PRODUCE BY: INFRASTRUCTURE SUPPORT TEAM ATH-CENTRAL OFFICE ELLIPTICAL ROAD, DILIMAN, QUEZON CITY	PREPARED BY:  PROJECT ENGINEER REGISTERED CIVIL ENGINEER PROJ. NO. 0001111111 DATE ISSUED: 02/02/24 DRAWN BY: DATE: 02/02/24 CHECKED BY: DATE: 02/02/24 PLACED ISSUED:	RECOMMENDING APPROVAL:  ANTONIETA J. ARCEO DIRECTOR III	APPROVED BY:  REMEL YVR. ACOSTA DIRECTOR IV	DESIGN BY: DATE: FEB 2024 CAD BY: JP DATE: FEB 2024 CHECKED BY: DATE: FEB 2024	SHEET NO.: D 03 03 03
---	---	--	--	--	--	---	---	---	--------------------------------